

SCALE: 3/8"=1'-0" (UNLESS OTHERWISE NOTED)

PREPARED FOR:

DRAWING NAME:

5000DS 1 LANE & 10FT WINDOW W/OUT DRAWER

08/18/10

DRAWN BY:  
CWP/FSP

APPROVED BY:  
—

REVISED:  
—


PROJECT NAME:

DRAWING NUMBER:

5000DS-1R-10W-0DD


SHEET:

1 OF 8

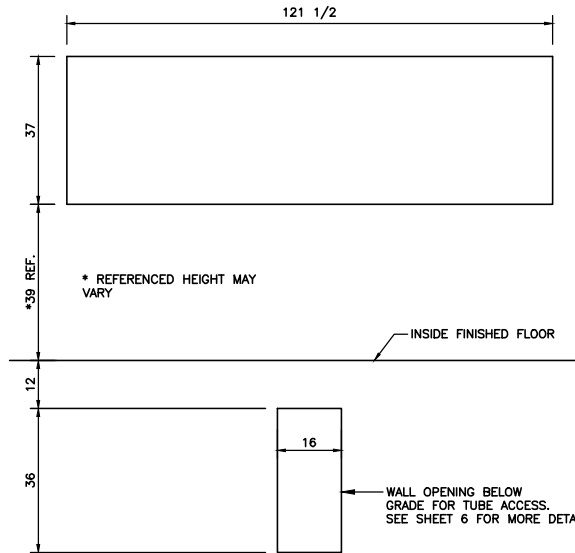


**INSIDE ELEVATION MASONRY OPENING**


- NOTE:**
- 10'-0" WINDOW SHOWN
  - DRAWER CUTOUT CAN BE POSITIONED ANYWHERE UNDER WINDOW.

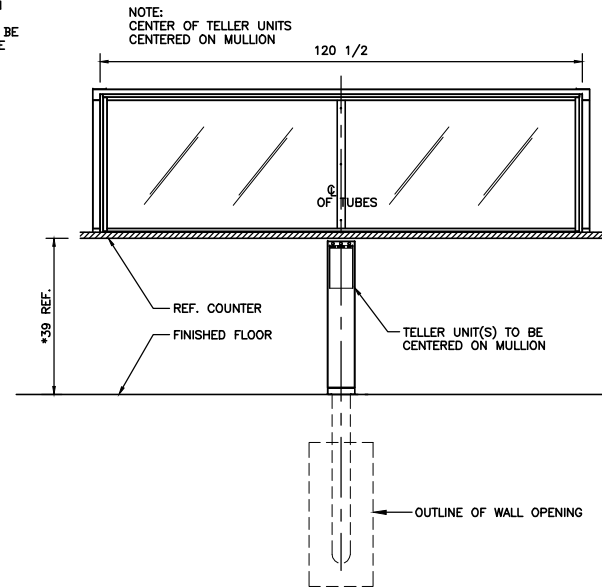

**INSIDE ELEVATION**

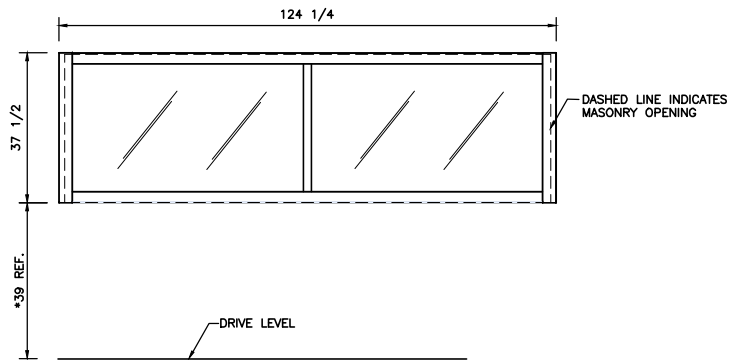

**FRONT ELEVATION**

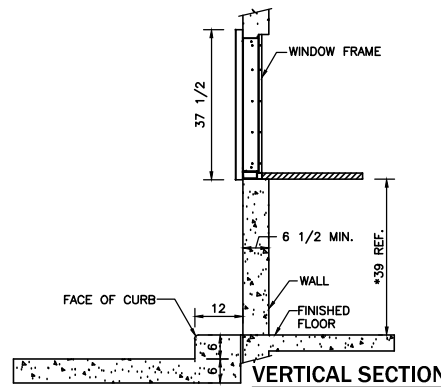

**VERTICAL SECTION**

SCALE: 1/4"=1'-0" (UNLESS OTHERWISE NOTED)

PREPARED FOR:

DRAWING NAME:

5000DS 1 LANE & 10FT WINDOW W/OUT DRAWER

08/18/10

DRAWN BY:  
CWP/FSP

APPROVED BY:  
—

REVISED:  
—


PROJECT NAME:

DRAWING NUMBER:

5000DS-1R-10W-0DD

SHEET:


2 OF 8

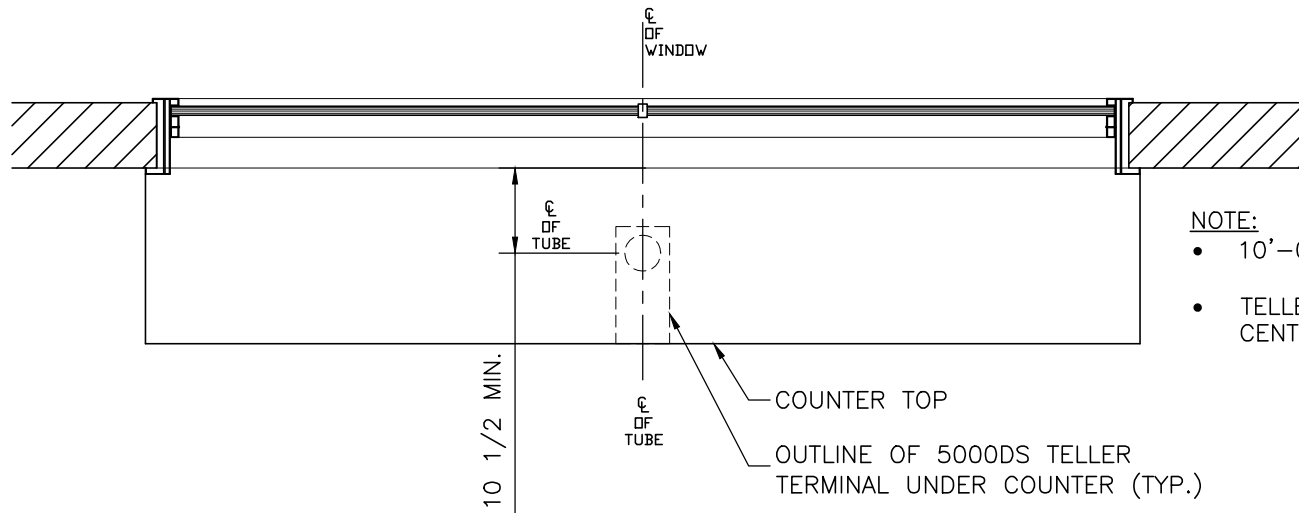

- NOTE:**
- 10'-0" WINDOW SHOWN
  - TELLER UNIT(S) TO BE CENTERED ON MULLION

**INSIDE PLAN VIEW AT DRIVE-UP COUNTER**

**5000DS TELLER UNIT**

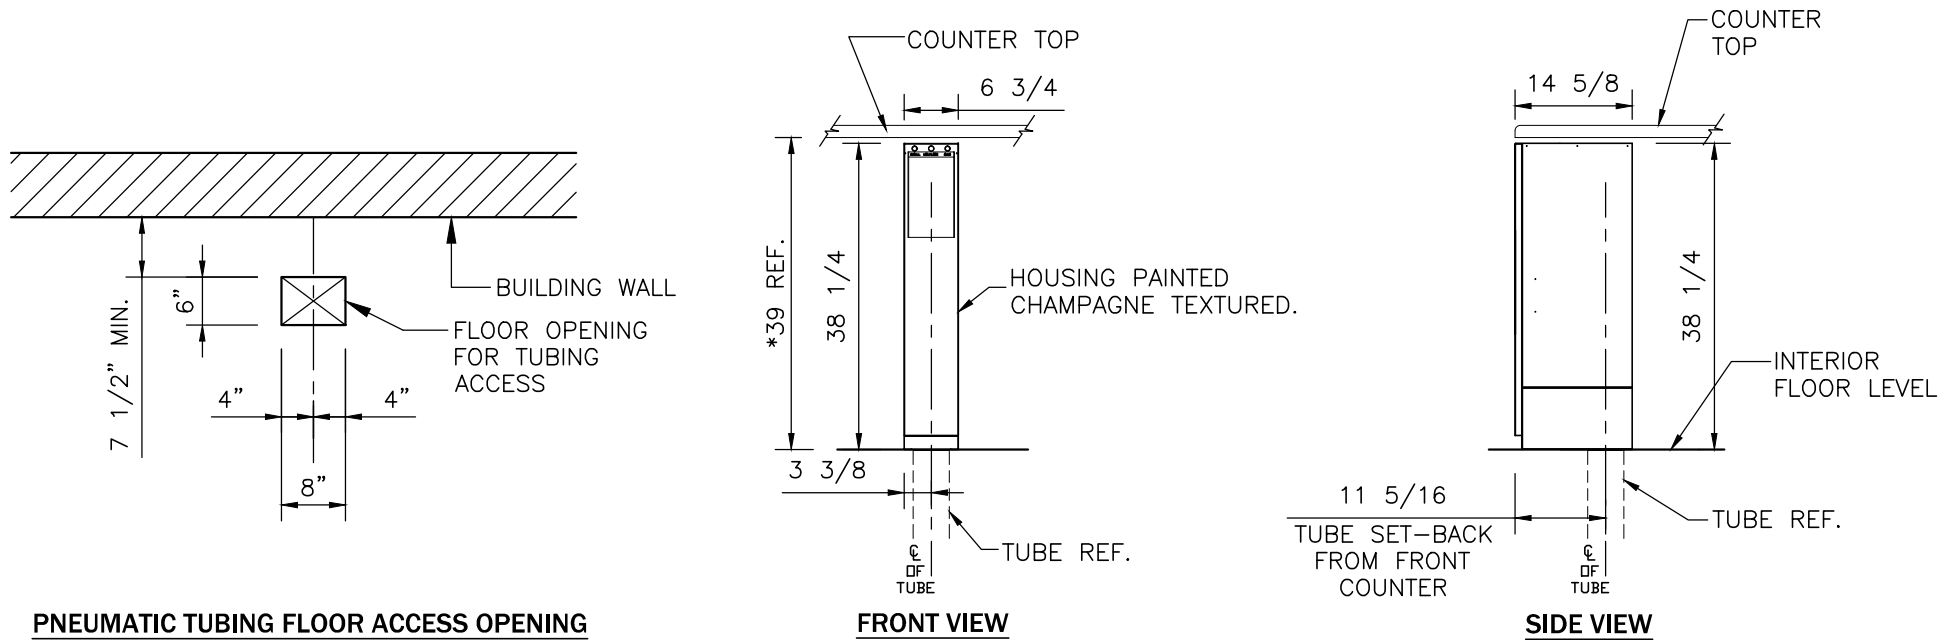


**PNEUMATIC TUBING FLOOR ACCESS OPENING**

**FRONT VIEW**

**SIDE VIEW**

SCALE: 1/2"=1'-0" (UNLESS OTHERWISE NOTED)

PREPARED FOR:				DRAWING NAME: 5000DS 1 LANE & 10FT WINDOW W/OUT DRAWER			
PROJECT NAME:				DRAWING NUMBER: 5000DS-1R-10W-0DD			
08/18/10	DRAWN BY: CWP/FSP	APPROVED BY: -	REVISED: -	SHEET: 3 OF 8			

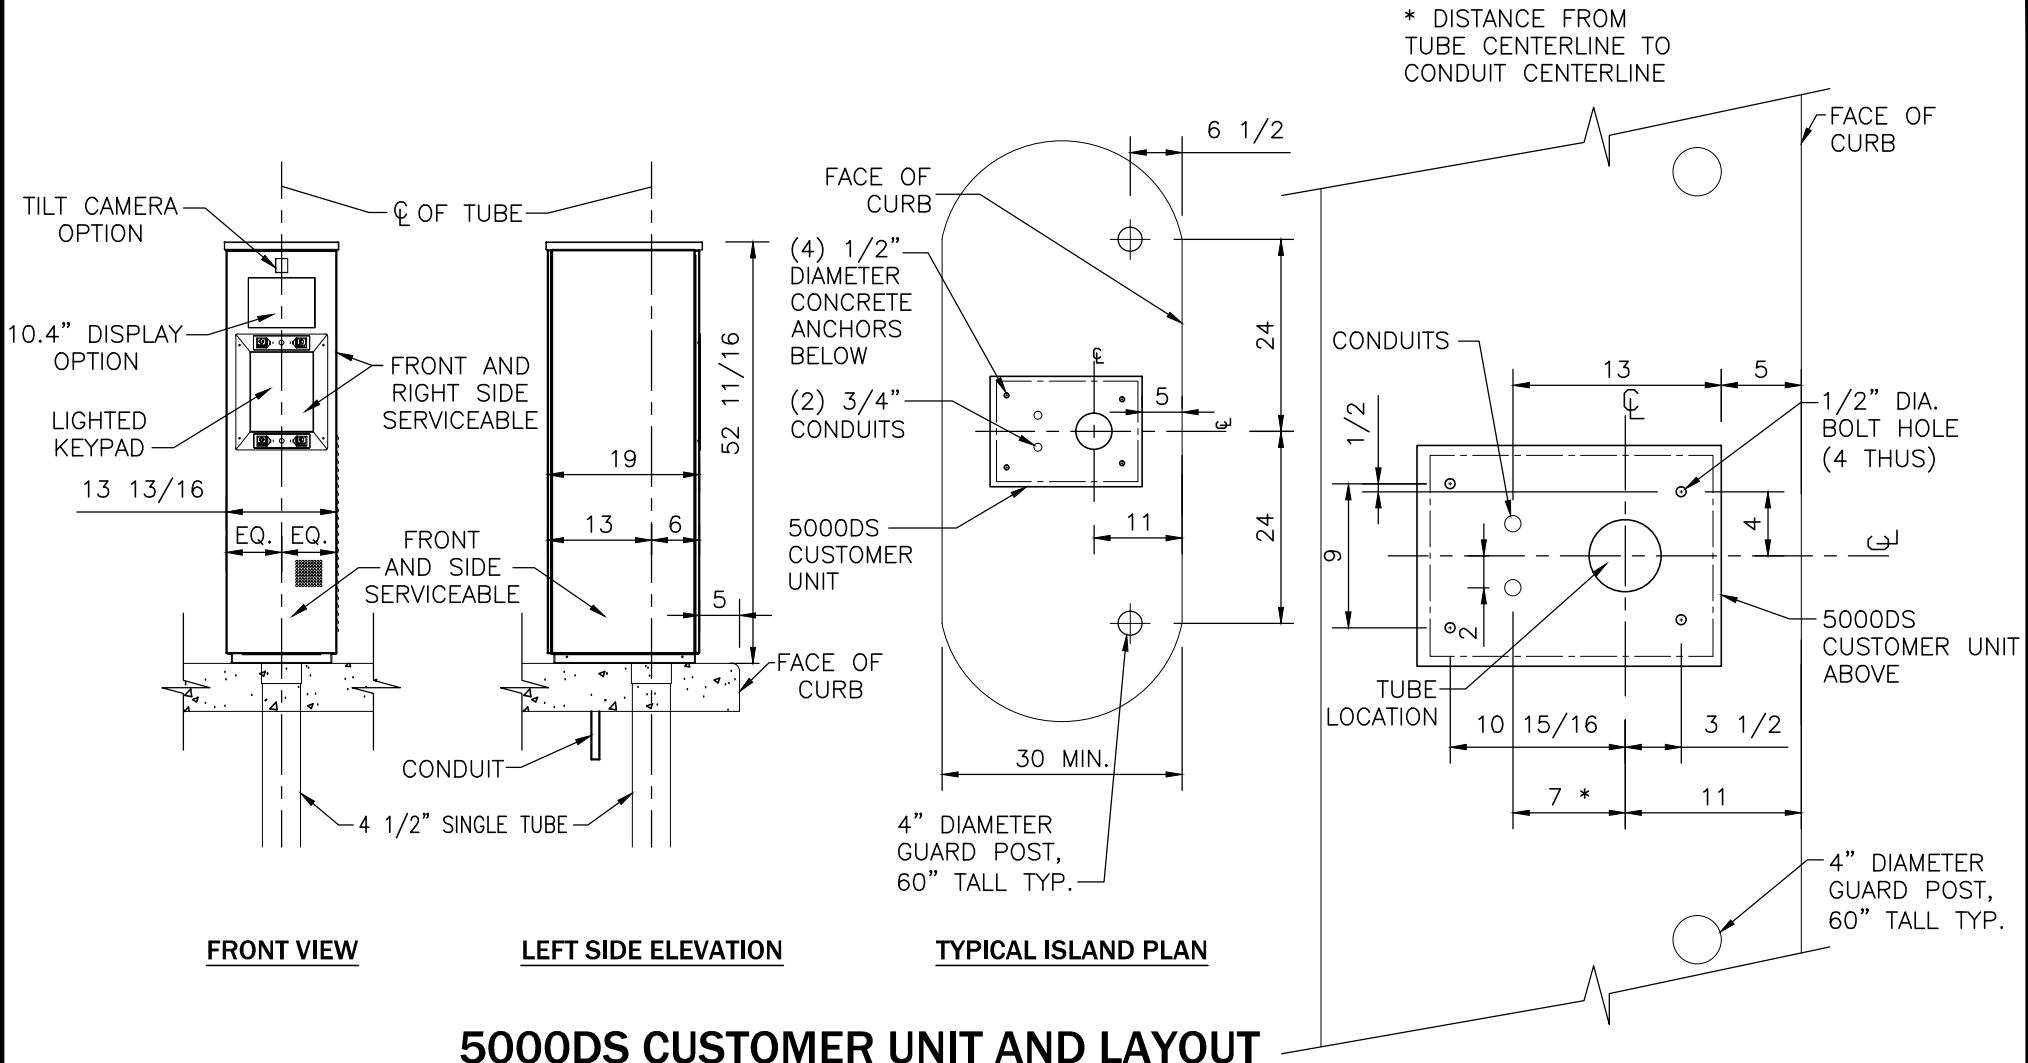

## 5000DS CUSTOMER UNIT AND LAYOUT

SCALE: 1/2"=1'-0" (UNLESS OTHERWISE NOTED)

PREPARED FOR:

DRAWING NAME:

5000DS 1 LANE & 10FT WINDOW W/OUT DRAWER

08/18/10

DRAWN BY:  
CWP/FSP

APPROVED BY:  
—

REVISED:  
—


PROJECT NAME:

DRAWING NUMBER:

5000DS-1R-10W-0DD

SHEET:

4 OF 8

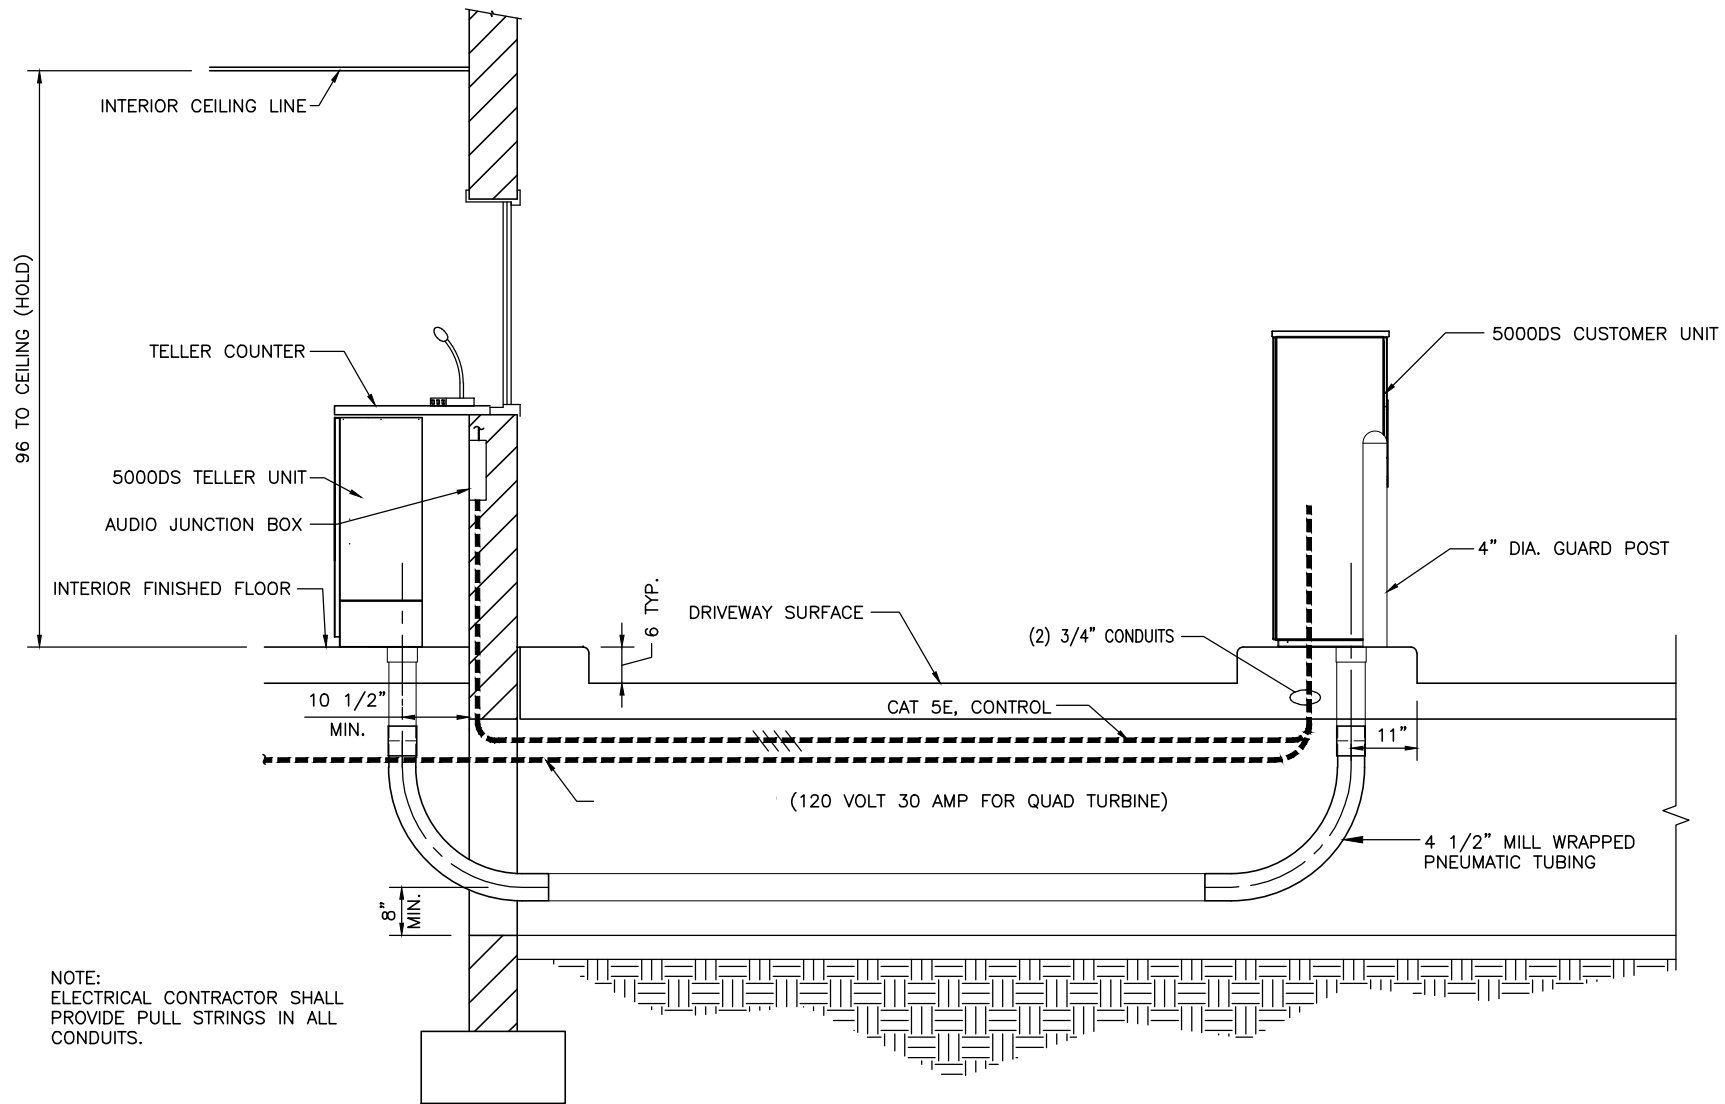

NOTE:  
ELECTRICAL CONTRACTOR SHALL  
PROVIDE PULL STRINGS IN ALL  
CONDUITS.

### DRIVE-UP SYSTEM VERTICAL SECTION

SCALE: 3/8"=1'-0" (UNLESS OTHERWISE NOTED)

PREPARED FOR:		DRAWING NAME: 5000DS 1 LANE & 10FT WINDOW W/OUT DRAWER	
08/18/10	DRAWN BY: CWP/FSP	APPROVED BY: —	REVISD: —
PROJECT NAME:		DRAWING NUMBER: 5000DS-1R-10W-0DD	SHEET: 5 OF 8

**LEGEND**


—/— REPRESENTS CONDUIT WITH A SINGLE JACKETED MULTICONDUCTOR OR COAXIAL LOW-VOLTAGE CABLE.

**NOTE:**


- (120 VOLT 30 AMP – FOR QUAD TURBINE)
- 120 VOLT 15 AMP – TELLER UNIT

**NOTE:**

THE TWO CONDUIT PATHWAYS SHOWN ON THIS DRAWING ARE TYPICAL OF THE CONDUIT REQUIREMENTS FOR EACH LANE.

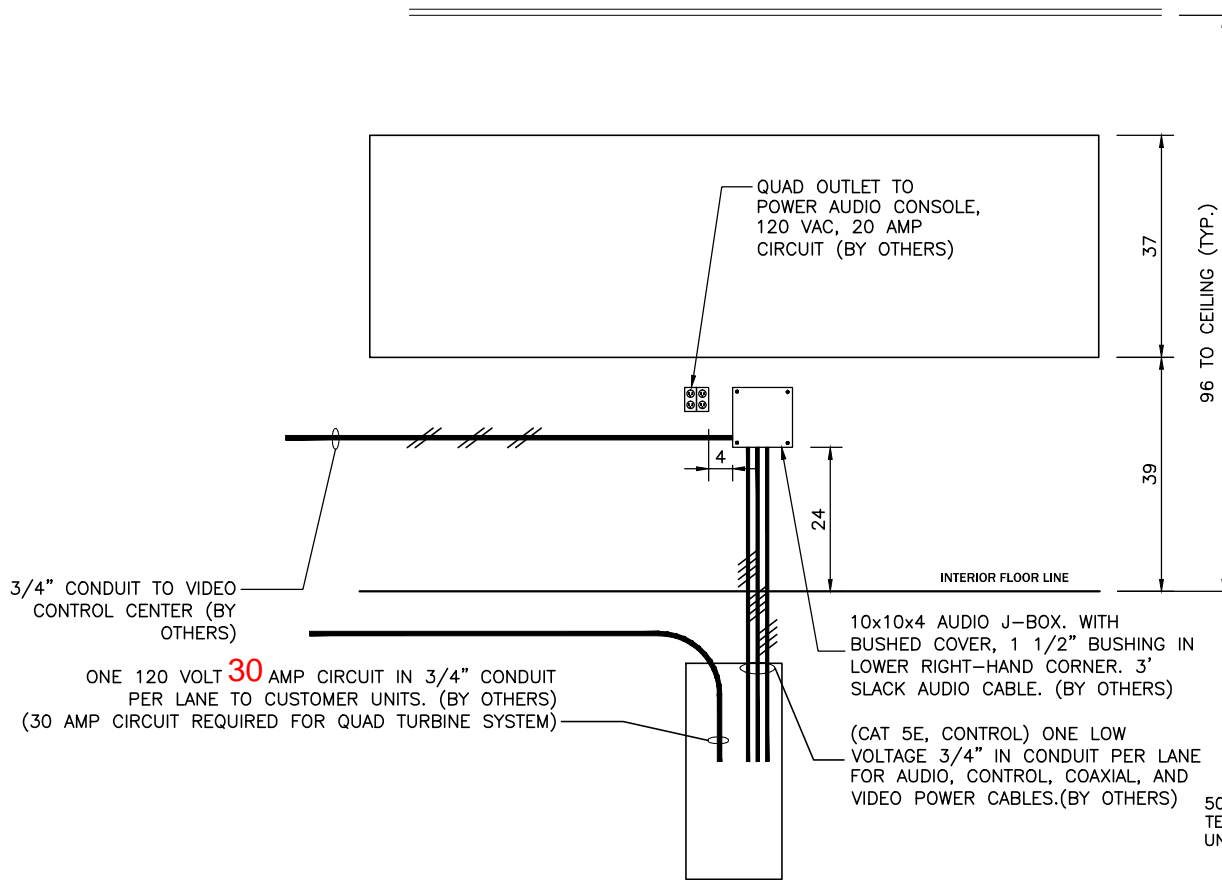

**WALL OPENING AND ELECTRICAL DETAIL**

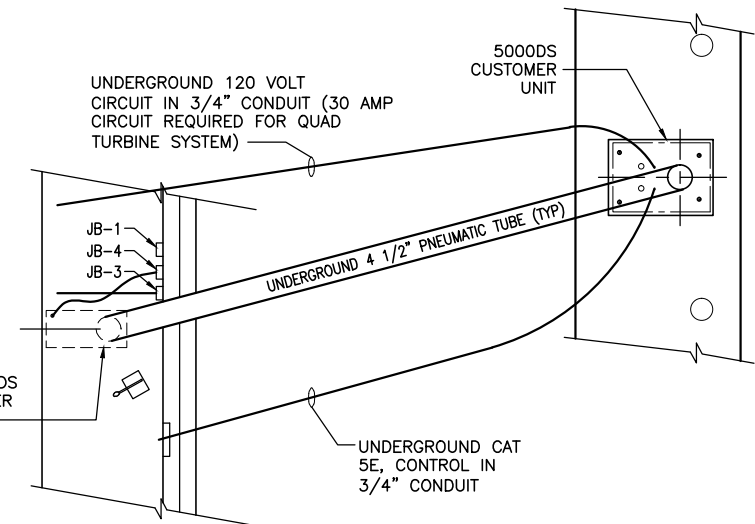

**TYPICAL ELECTRICAL LAYOUT**

N.T.S.

SCALE: 3/8"=1'-0" (UNLESS OTHERWISE NOTED)

PREPARED FOR:		DRAWING NAME: 5000DS 1 LANE & 10FT WINDOW W/OUT DRAWER	
PROJECT NAME:		DRAWING NUMBER: 5000DS-1R-10W-0DD	
DRAWN BY: CWP/FSP	APPROVED BY: —	REVISID: —	SHEET: 6 OF 8

08/18/10

DRAWN BY:  
CWP/FSP


APPROVED BY:  
—

REVISID:  
—

PROJECT NAME:

DRAWING NUMBER:  
5000DS-1R-10W-0DD

SHEET:  
6 OF 8

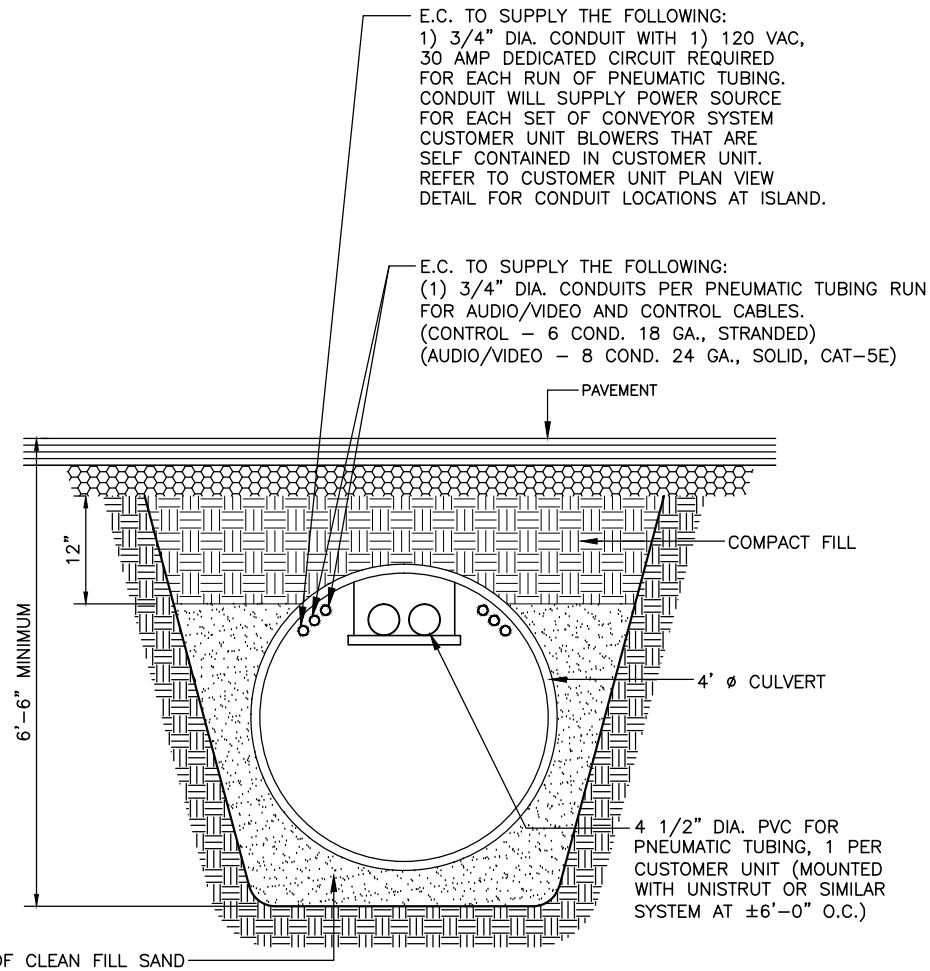

**CULVERT SECTION**

SCALE: NO SCALE

**NOTE:**

G.C. TO PROVIDE OSHA APPROVED TRENCH FROM BUILDING WALL TO CUSTOMER UNIT ISLANDS. ACTUAL ROUTING OF TRENCH TO BE DETERMINED BY THE G.C. DEPTH OF TRENCH MAY VARY TO AVOID OBSTRUCTIONS, BUT MUST NOT BE LESS THAN THE MINIMUM AS SHOWN IN THE THE TYPICAL TRENCH SECTION. G.C. TO VERIFY LOCATION OF ALL UTILITIES, SEWER, WATER, ETC. AND ROUTE TRENCH AROUND OBSTRUCTIONS.

VERIFY TRENCH DEPTH, TO BE DETERMINED BY THE FROST DEPTH.

SCALE: 3/8"=1'-0" (UNLESS OTHERWISE NOTED)

PREPARED FOR:

DRAWING NAME:

5000DS 1 LANE & 10FT WINDOW W/OUT DRAWER

DRAWN BY:

APPROVED BY:

REVISED:

PROJECT NAME:

DRAWING NUMBER:

SHEET:

08/18/10


CWP/FSP

—

—

5000DS-1R-10W-0DD

7 OF 8

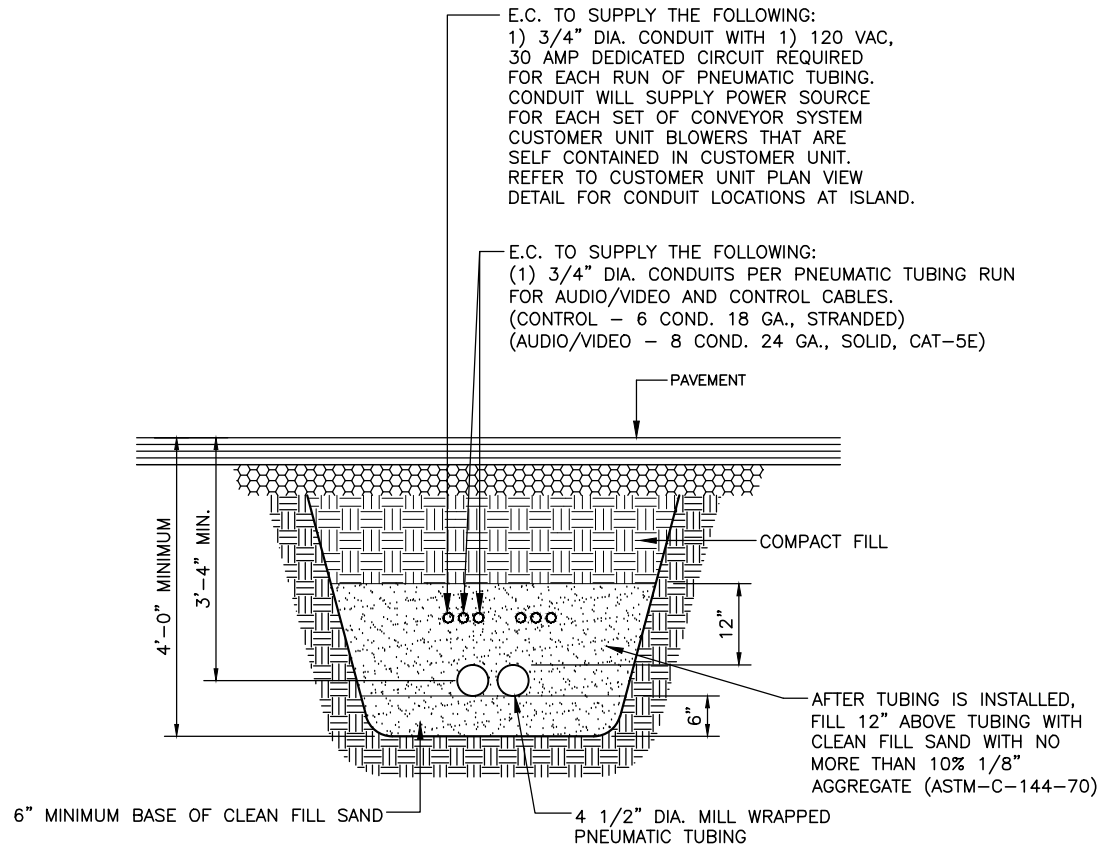

### TRENCH SECTION

SCALE: NO SCALE

**NOTE:**

G.C. TO PROVIDE OSHA APPROVED TRENCH FROM BUILDING WALL TO CUSTOMER UNIT ISLANDS. ACTUAL ROUTING OF TRENCH TO BE DETERMINED BY THE G.C. DEPTH OF TRENCH MAY VARY TO AVOID OBSTRUCTIONS, BUT MUST NOT BE LESS THAN THE MINIMUM AS SHOWN IN THE THE TYPICAL TRENCH SECTION. G.C. TO VERIFY LOCATION OF ALL UTILITIES, SEWER, WATER, ETC. AND ROUTE TRENCH AROUND OBSTRUCTIONS.

VERIFY TRENCH DEPTH, TO BE DETERMINED BY THE FROST DEPTH.

SCALE: 3/8"=1'-0" (UNLESS OTHERWISE NOTED)

PREPARED FOR:			DRAWING NAME: 5000DS 1 LANE & 10FT WINDOW W/OUT DRAWER		
08/18/10	DRAWN BY: CWP/FSP	APPROVED BY: —	REVISED: —	PROJECT NAME:	DRAWING NUMBER: 5000DS-1R-10W-0DD
					SHEET: 8 OF 8